




THIS EDGE INTENTIONALLY LEFT BLANK FOR BINDING - PAPER SIZE 34" X 22" - THIS EDGE INTENTIONALLY LEFT BLANK FOR BINDING - PAPER SIZE 34" X 22" - THIS EDGE INTENTIONALLY LEFT BLANK FOR BINDING - PAPER SIZE 34" X 22" - THIS EDGE INTENTIONALLY LEFT BLANK FOR BINDING - PAPER SIZE 34" X 22"

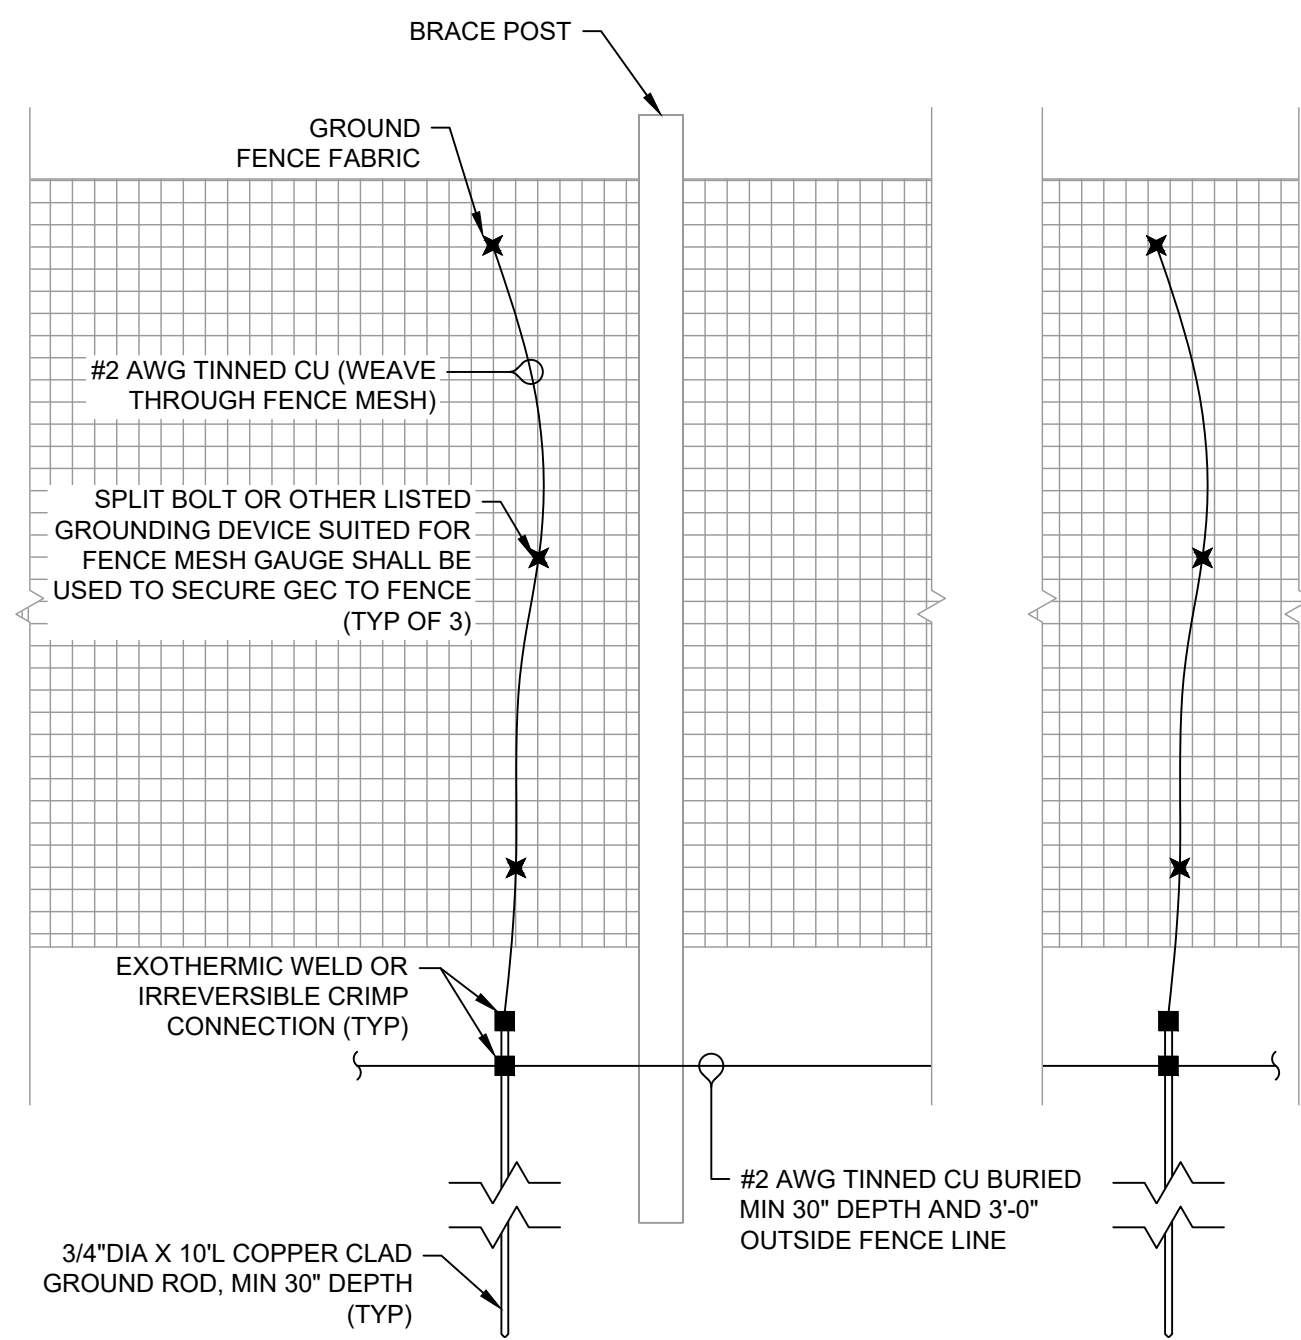


1 FENCE POST GRONDING ELEVATION
SCALE: NTS

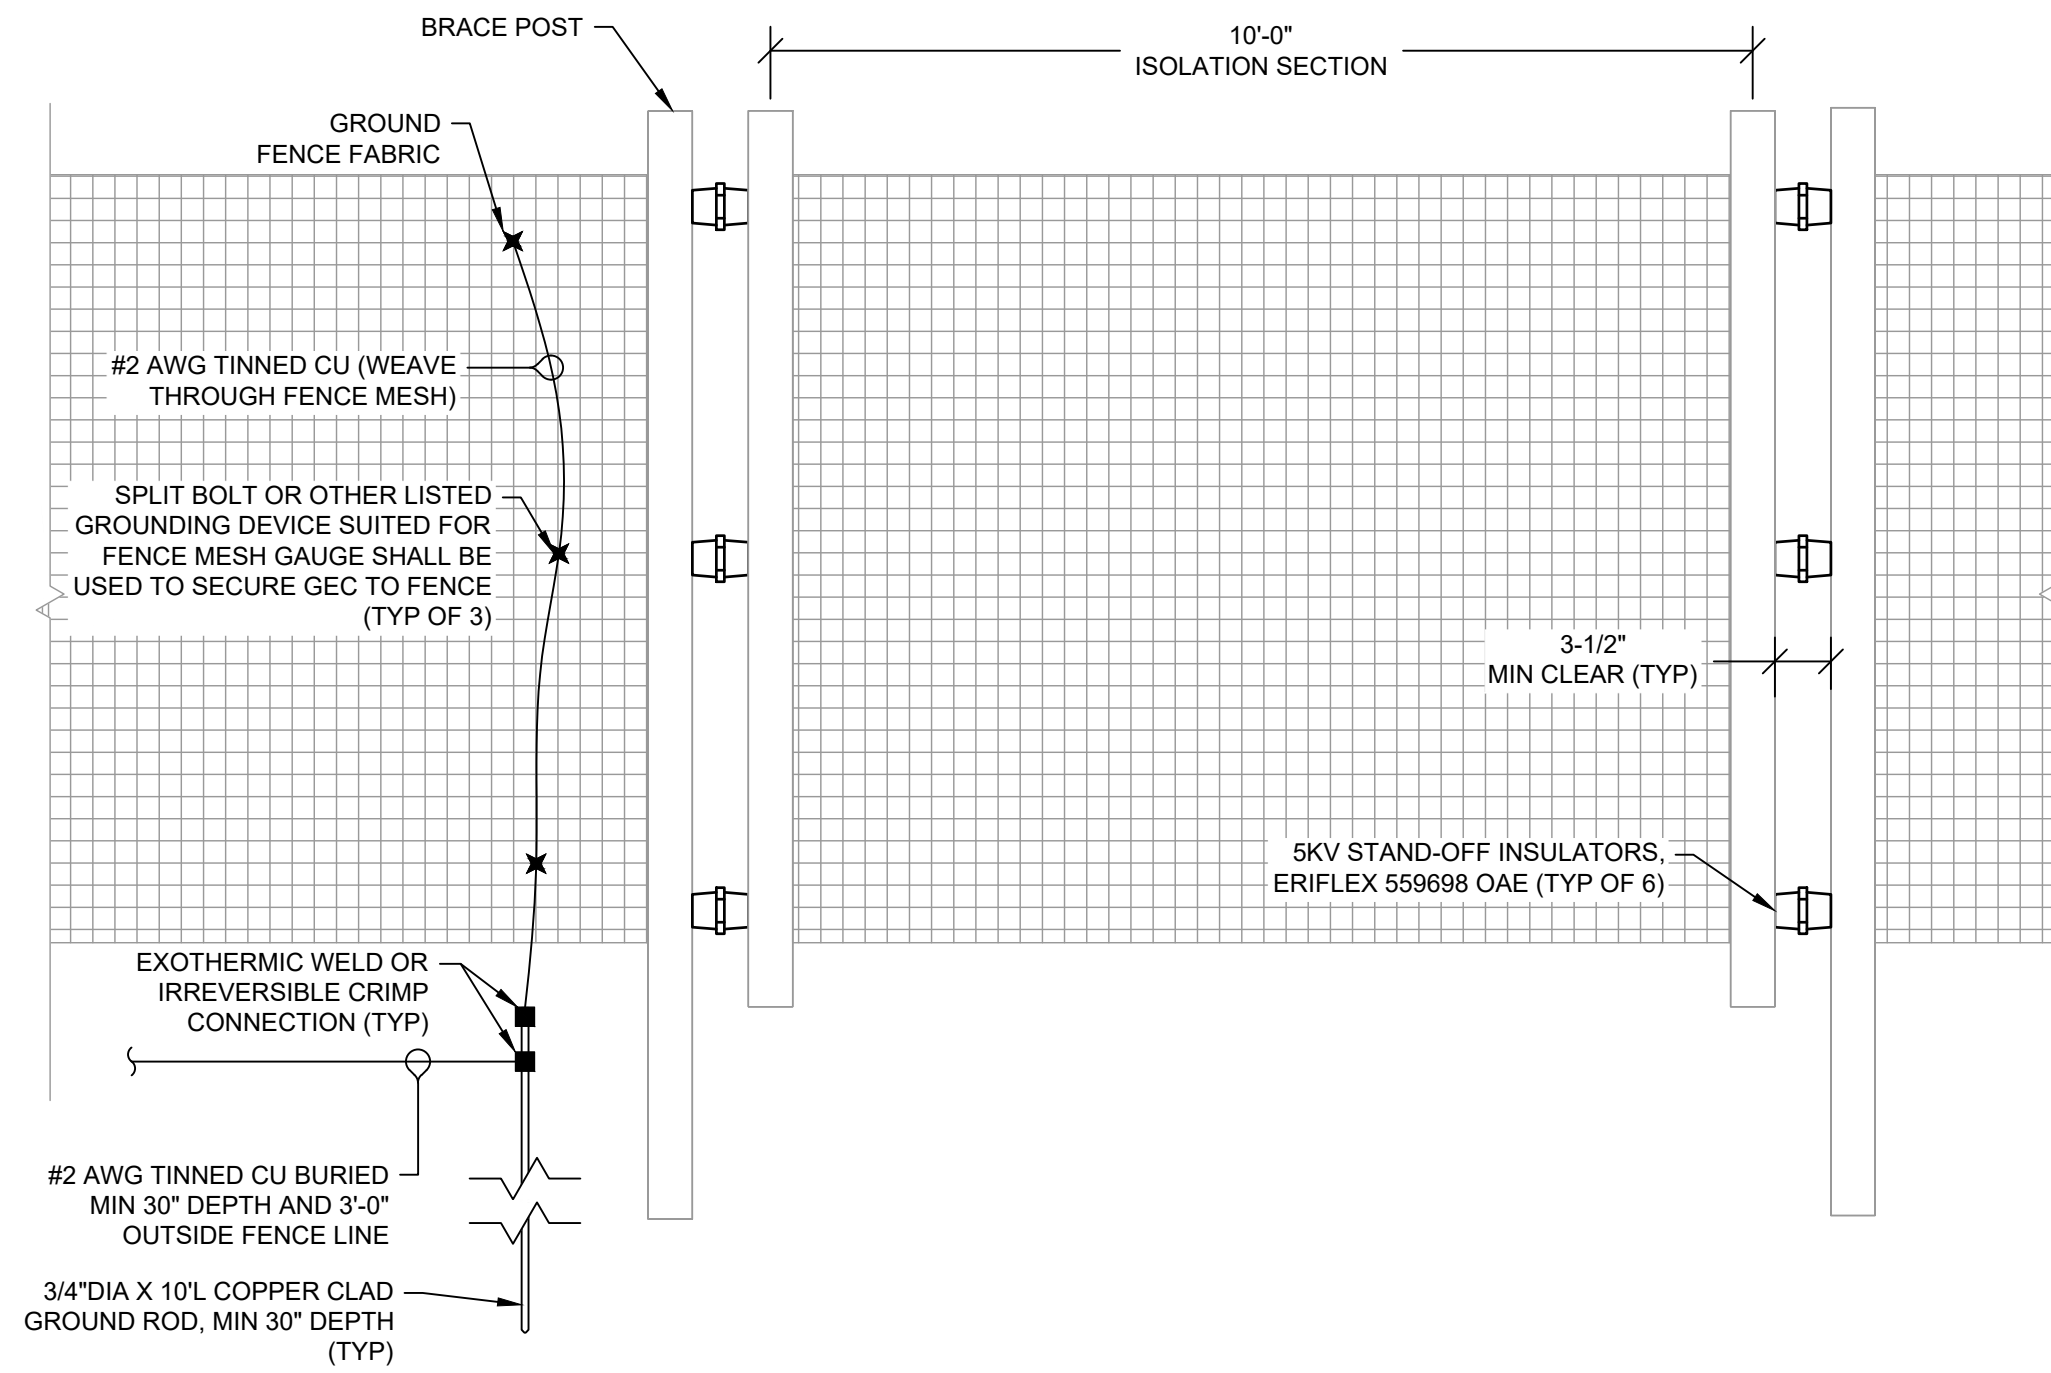

2 ISOLATION FENCE ELEVATION
SCALE: NTS

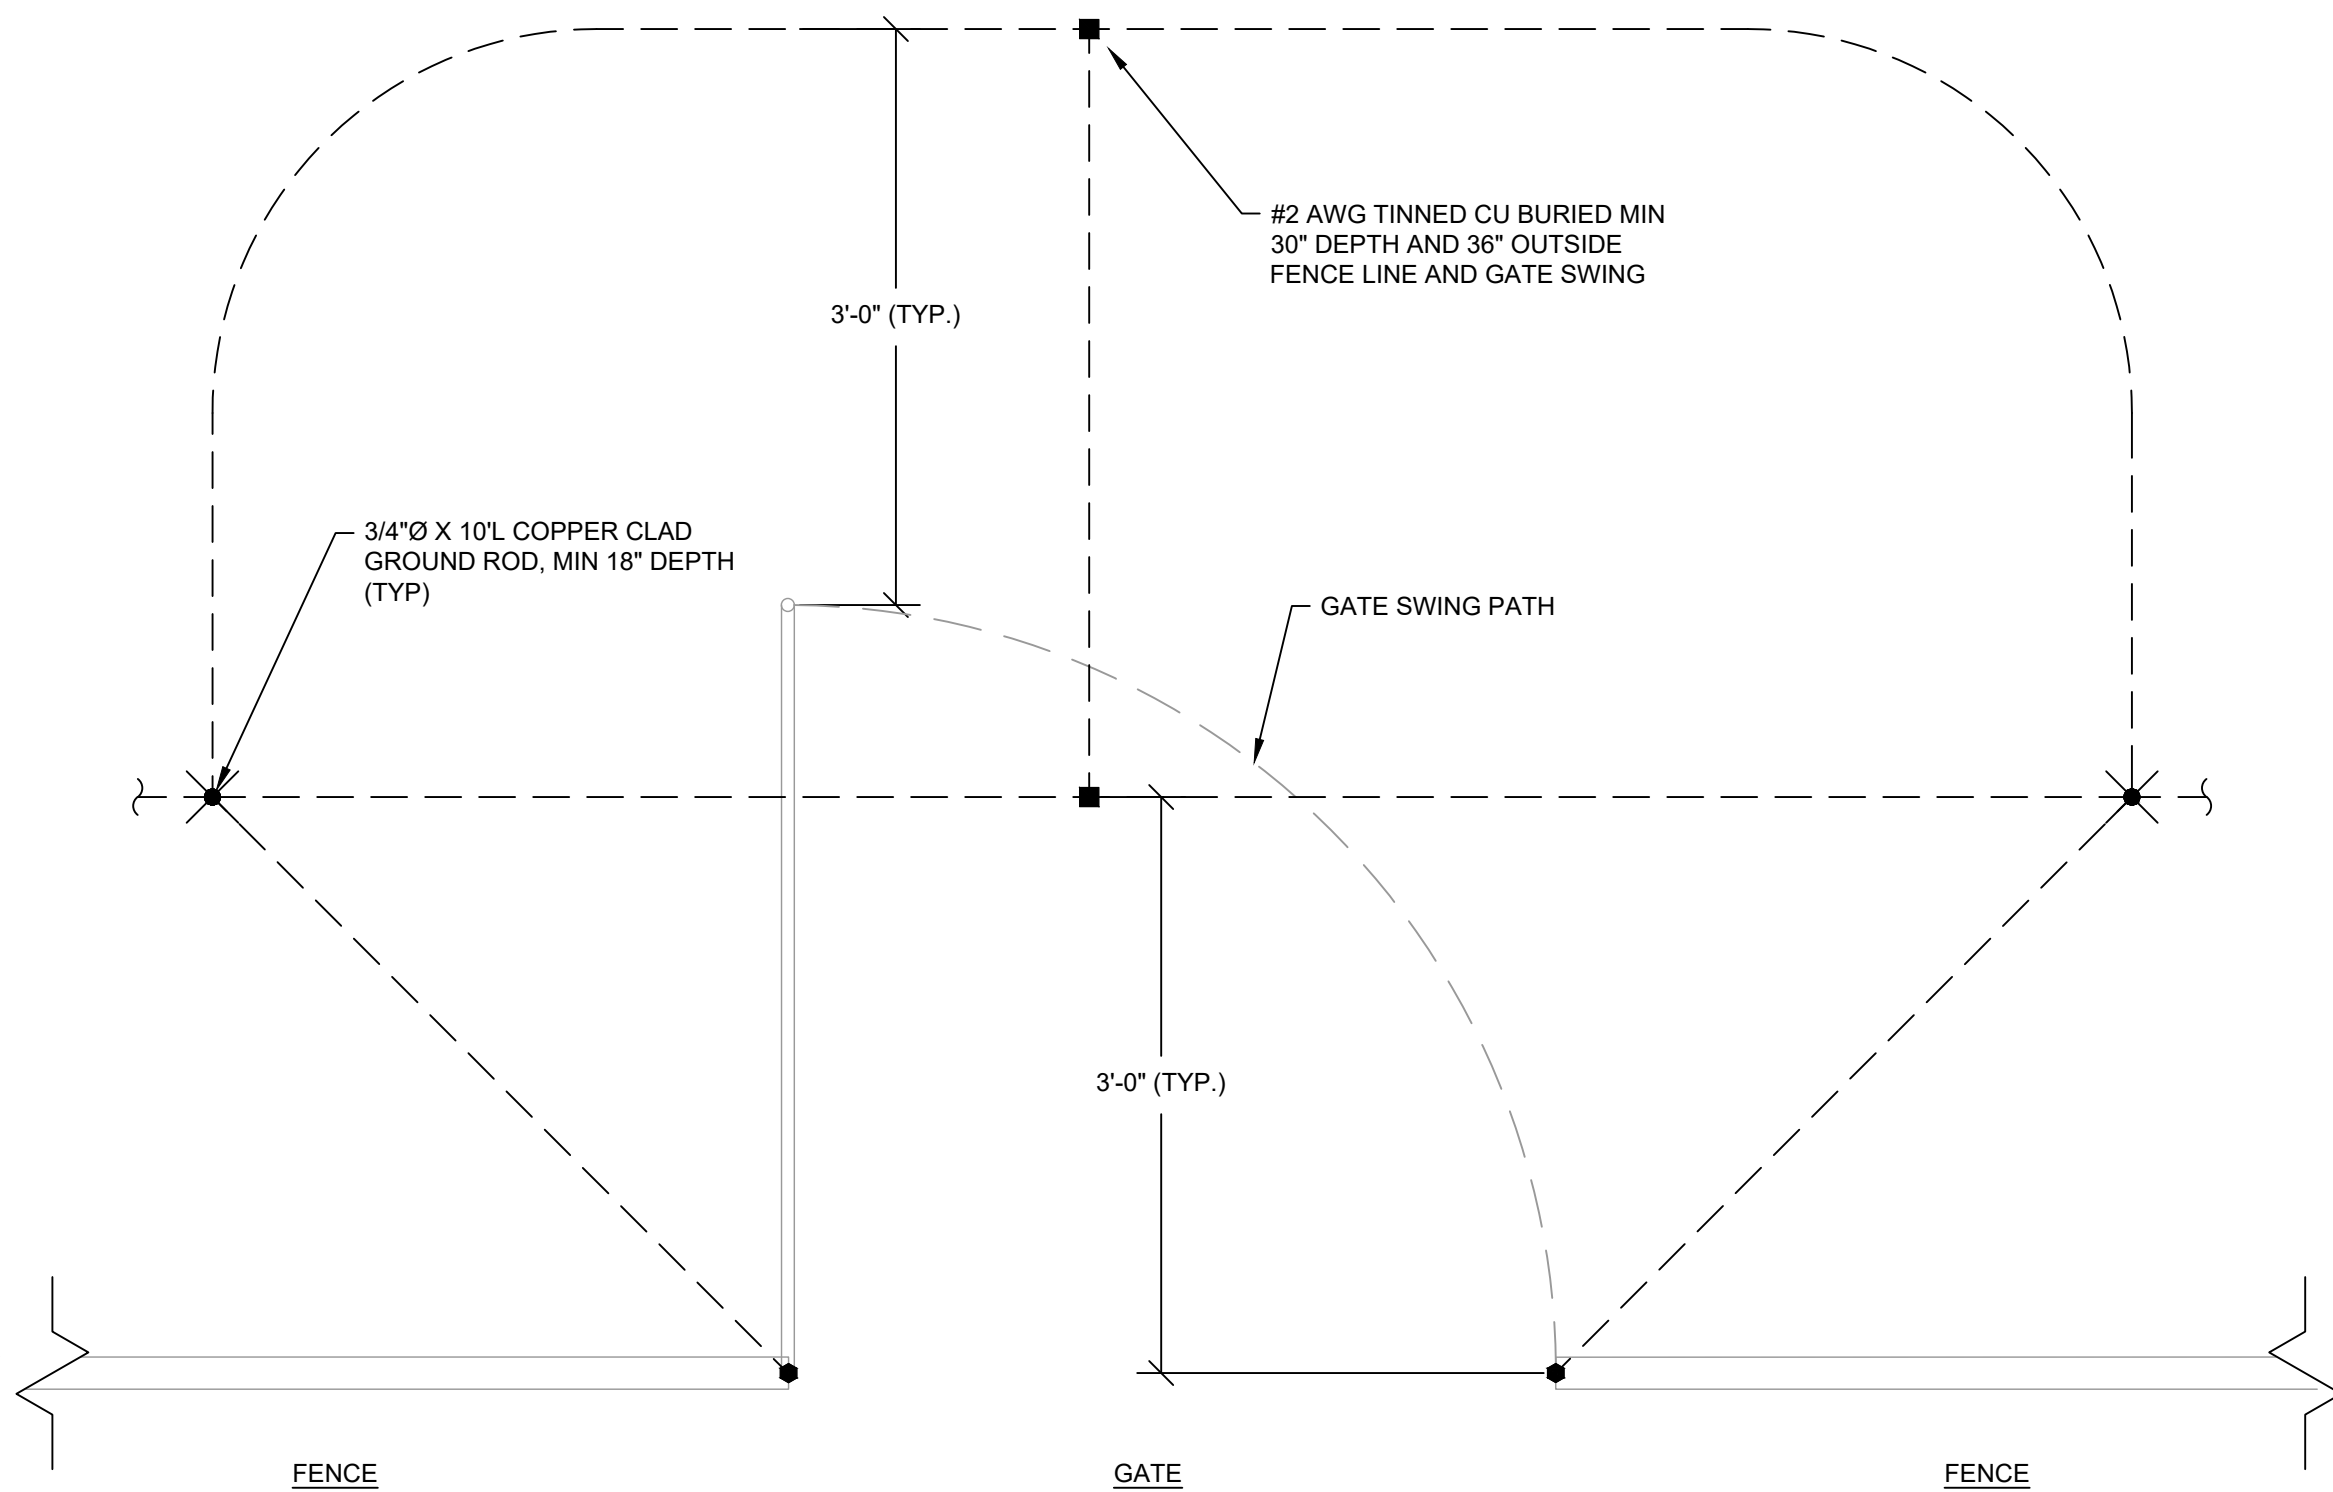

3 4' PERSONNEL GATE GROUNDING PLAN SCALE: NTS

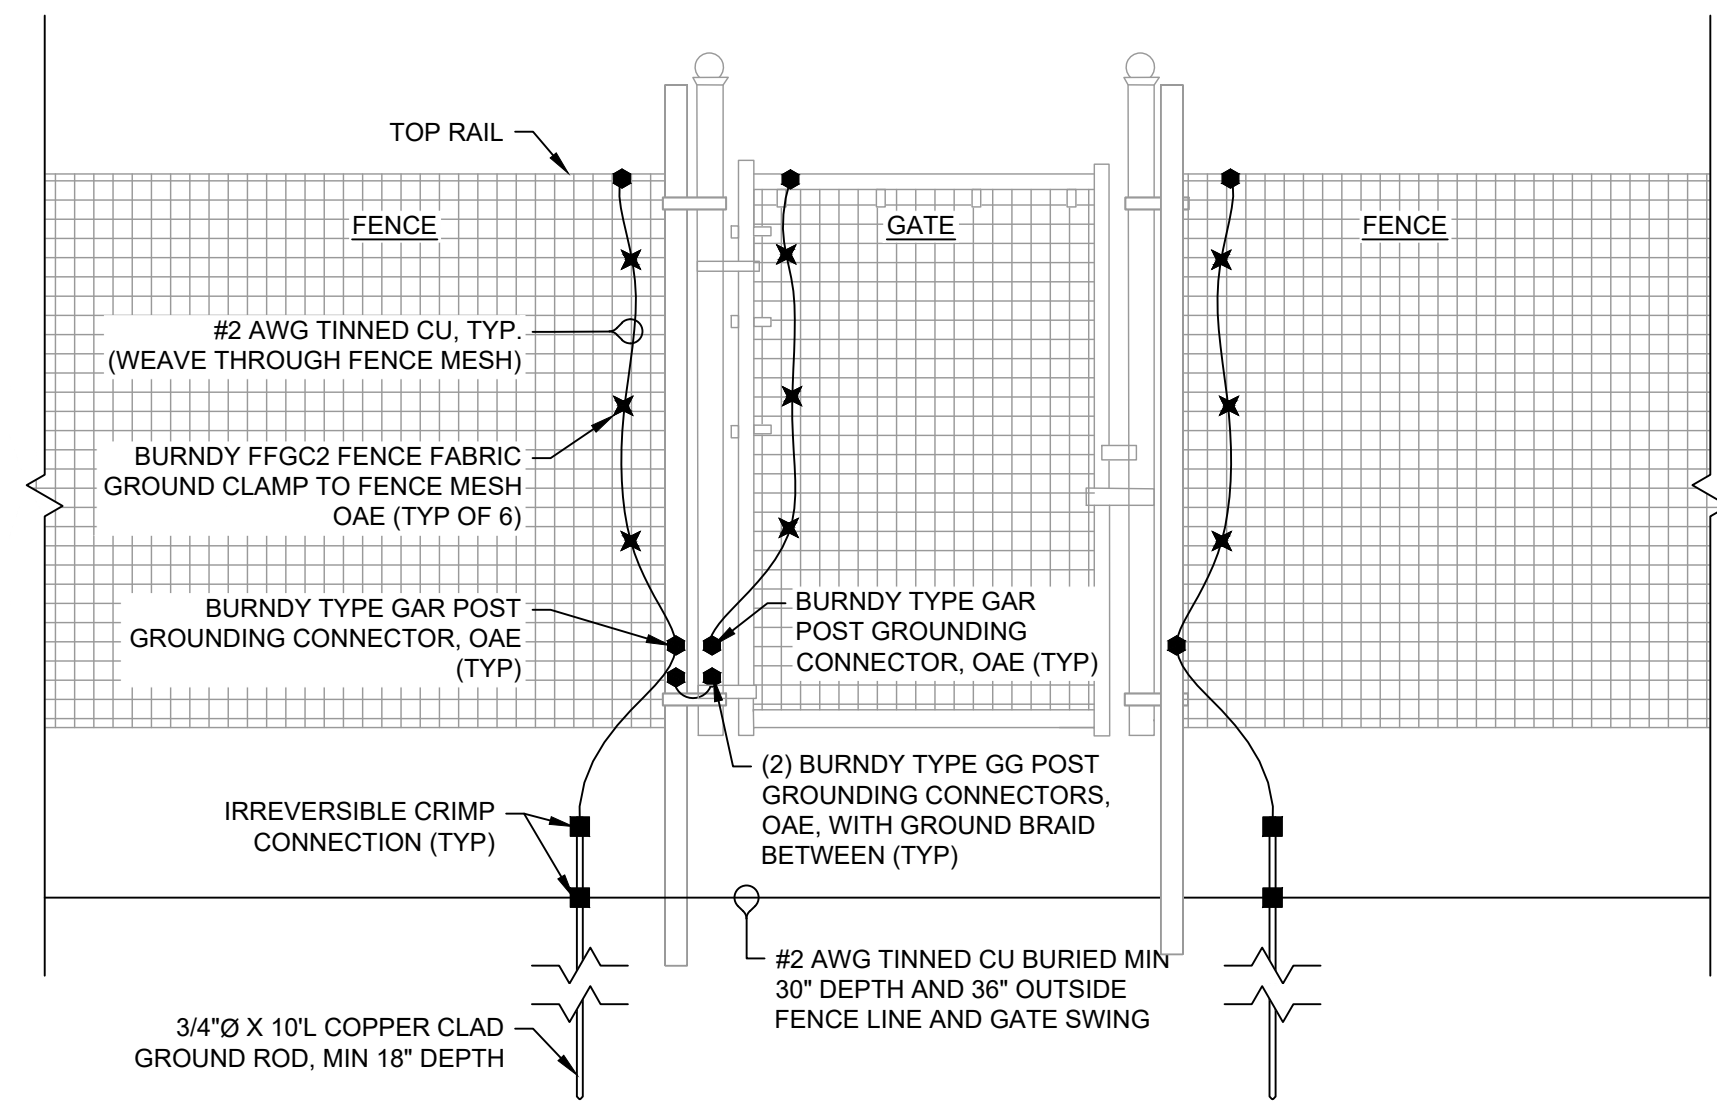

4 FENCE GATE GROUNDING ELEVATION SCALE: NTS

SHEET NOTES:

1. FENCING SPECIFICS ARE DIAGRAMMATIC AS SHOWN (MESH, POST, ETC) AND ARE DESIGNED BY OTHERS.
2. ALL FENCE SECTIONS ARE ASSUMED TO BE WOVEN. TOGETHER TO CREATE CONTINUOUS PIECE OF FENCE FABRIC AND THE BOND TO GROUND SHOULD OCCUR AT EACH END.
3. WHERE FENCE MUST BE GROUNDED CONTRACTOR SHALL GROUND FENCE CORNER POSTS, END POSTS, AND AT MAXIMUM 150FT INTERVALS OF FENCE SECTION AT THE MINIMUM. BOND ALL NON-CONTINUOUS FENCE SECTIONS WHICH ARE NOT OTHERWISE BONDED WITH #2 AWG TINNED CU.
4. DO NOT CONNECT FENCE GROUND SYSTEM TO ARRAY GROUND SYSTEM.
5. WITHIN GROUNDED FENCE SECTIONS, TO ENSURE PROPER GROUNDING OF EACH FENCE POST, CONTRACTOR TO PERFORM GROUNDING SYSTEM TEST AT 3 OR 3 POINT FALL-OF-POTENTIAL METHOD. IF REQUIRED, CONTRACTOR TO BOND FENCE POST TO GROUNDED MESH SECTION USING #2 AWG TINNED CU.

LEGEND:

- EXOTHERMIC WELD OR
IRREVERSIBLE CRIMP CONNECTION
 ✕ OTHER BONDED CONNECTION

DESIGN COORDINATOR



KNOBELSDORFF

25701 370TH STREET
GOODHUE, MN 55027

PROJECT

**138883 CEMETERY
SUN, LLC**

24638 ADAMS RD,
FREDERICK, IL 62639
40.089020°, -90.442132°

ENGINEER



STELLAVISE
SOLAR ENGINEERING

2535 CAMINO DEL RIO S, STE. 235
SAN DIEGO, CA 92108
IL DESIGN FIRM #184.009162

WWW.STELLAVISE.COM

(619) 837-5331

SEAL



THIS DRAWING AND ALL INFORMATION HEREIN IS THE PROPERTY OF STELLAVISE INC. ANY REPRODUCTION, MODIFICATION OR USE OF THIS DRAWING FOR OTHER THAN THE INTENDED PROJECT WITHOUT PRIOR WRITTEN AUTHORIZATION FROM STELLAVISE INC. IS STRICTLY FORBIDDEN.

REVISIONS

| # | DESCRIPTION | DATE |
|---|-------------|------------|
| 0 | IFC | 02/06/2026 |
| 1 | IFC R1 | 02/27/2026 |

ISSUED FOR CONSTRUCTION
FEBRUARY 27, 2026

138883 CEMETERY
SUN, LLC
FREDERICK, IL, 62639

SHEET TITLE

ELECTRICAL DETAILS - FENCE GROUNDING

SHEET NO.

E-603